

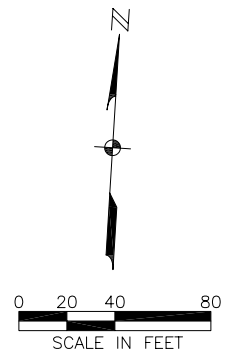


FOR CONTINUATION SEE SHEET PP 9

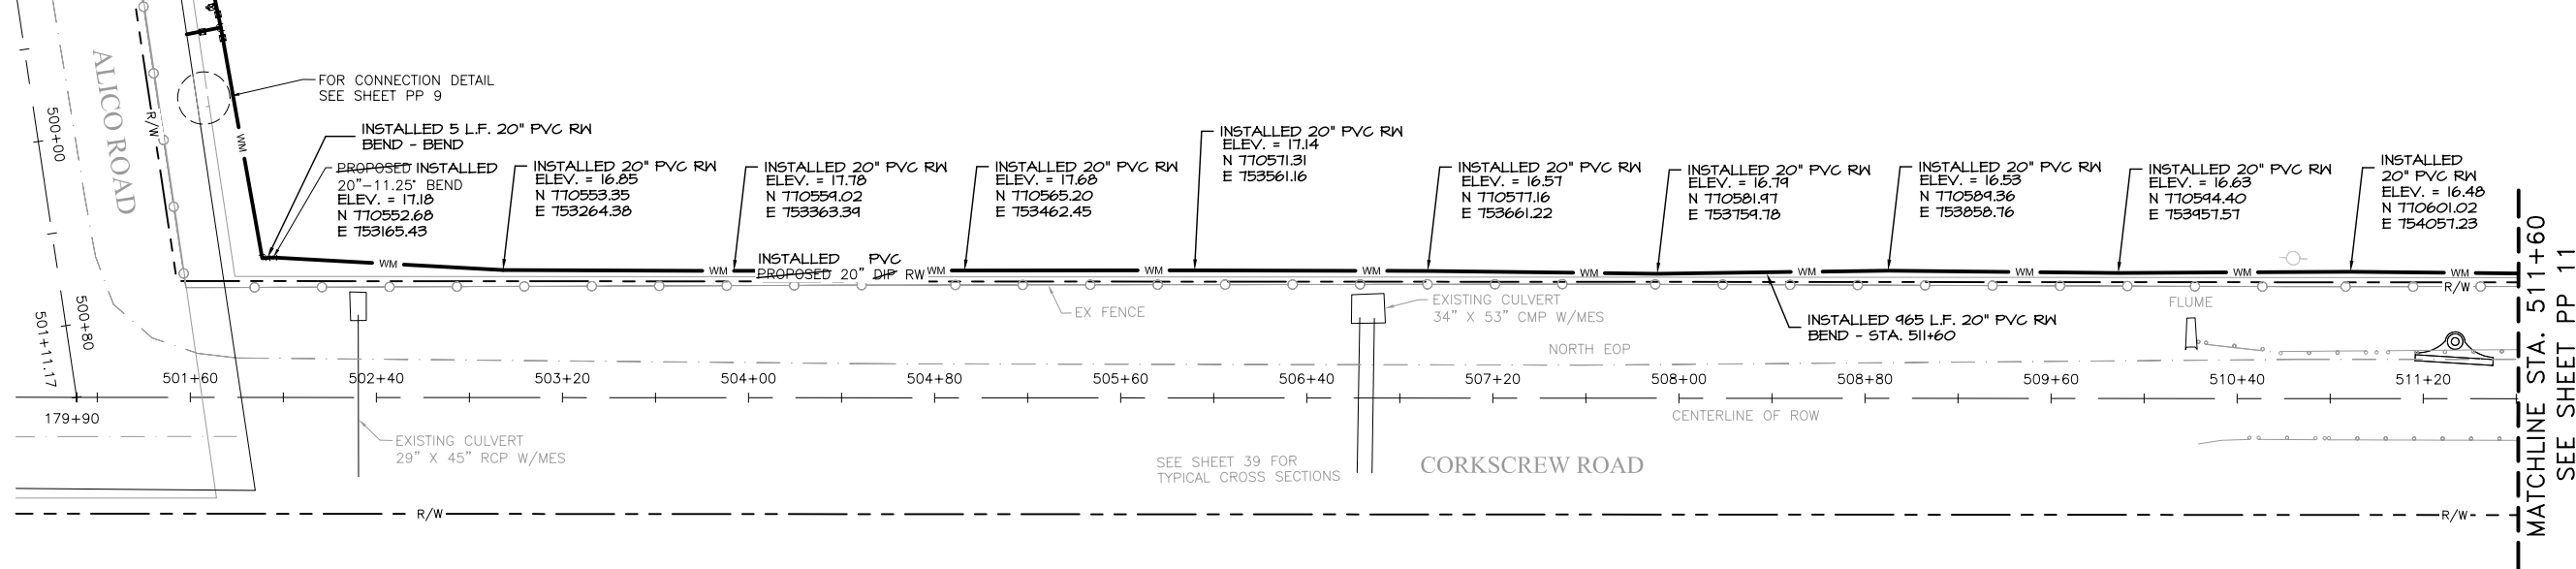

NOTE:
USE EXTREME CAUTION.
OVERHEAD POWER IN AREA.

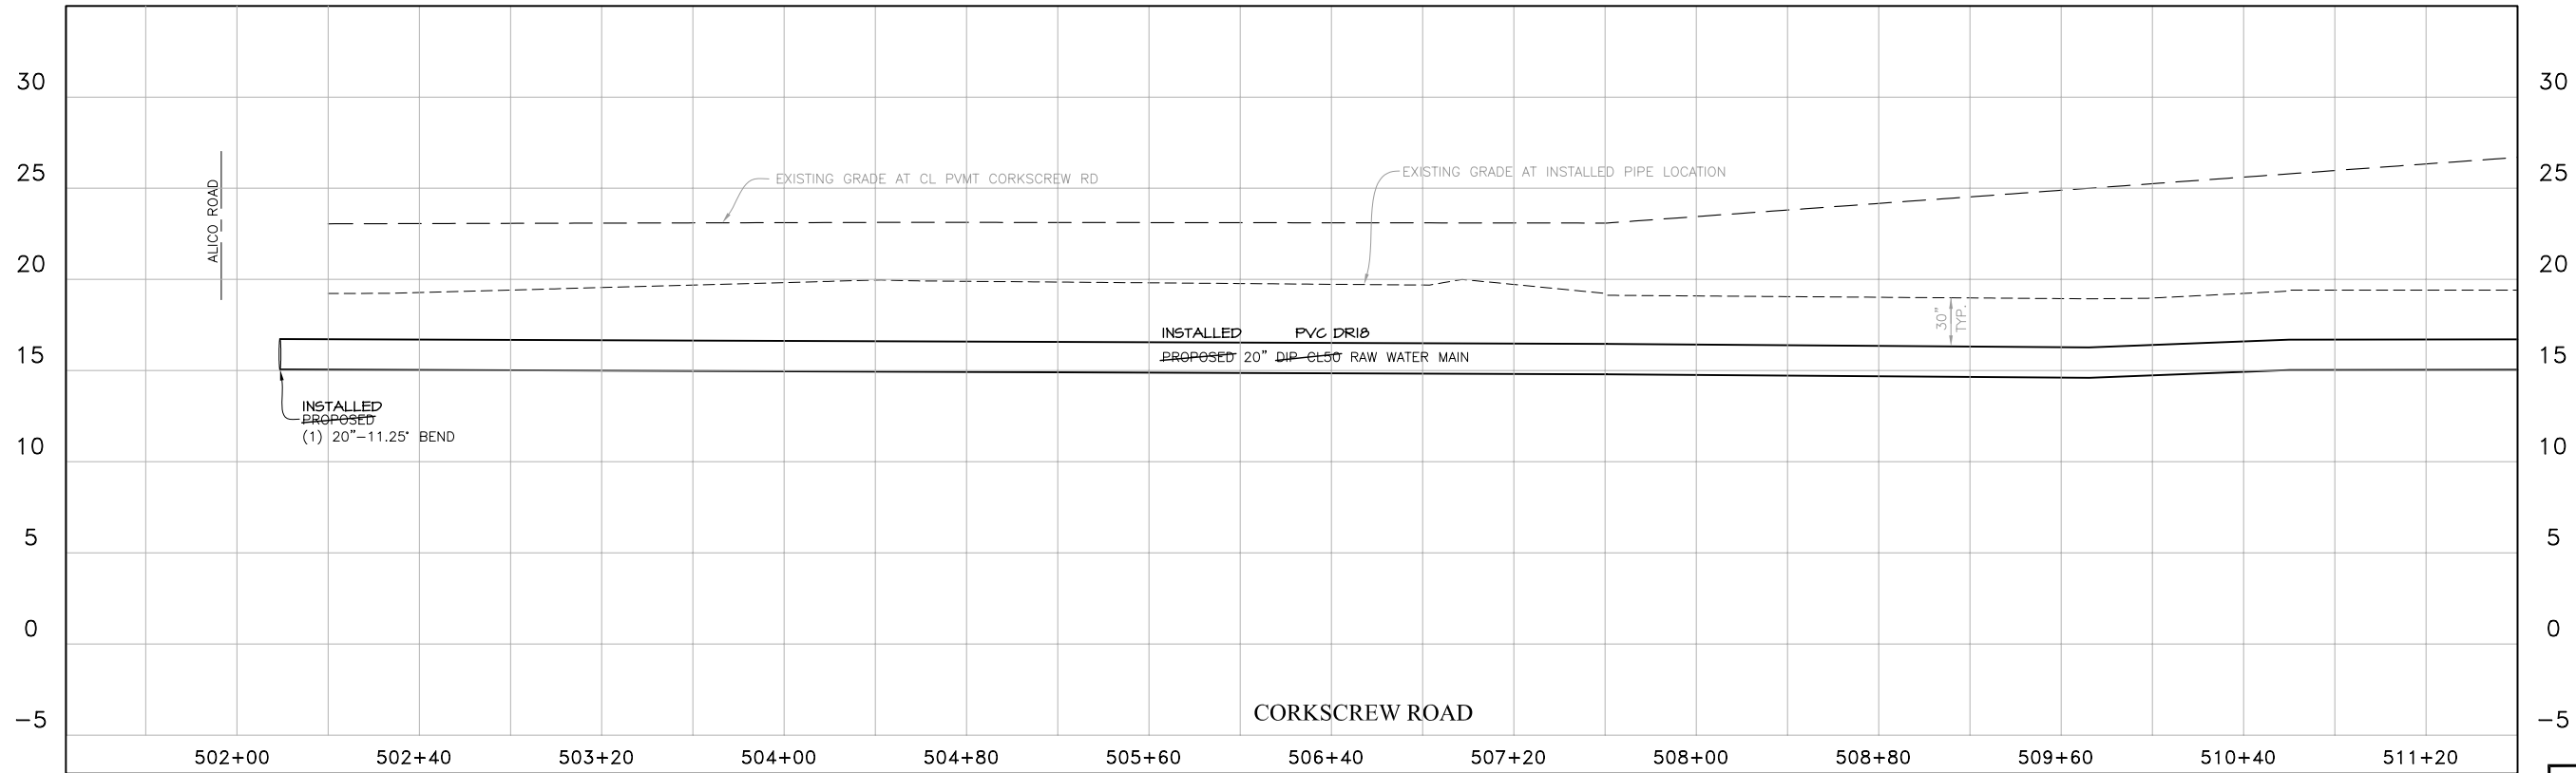

SCALE 1" = 40' HOR
1" = 5' VER


RECORD DRAWING

\\Ftms01\proj-jei\20033735\WaterMgmt\RECORD DRAWINGS\PP-WTP_to CorkscrewE1.dwg (PP 10) jwm Oct 05, 2009 - 8:52am

REVISIONS	



Corkscrew 5 MGD
Wellfield Expansion

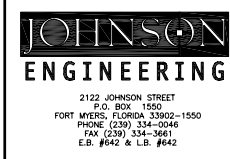

ERIK LEE HOWARD, PE
FL License No. 66574

Plan and Profile - WTP to Corkscrew East
Sta. 501+60 to Sta. 511+60

DATE	PROJECT NO.	FILE NO.	SCALE	SHEET
MARCH, 2006	20033735	16-46-26	As Shown	PP 10