
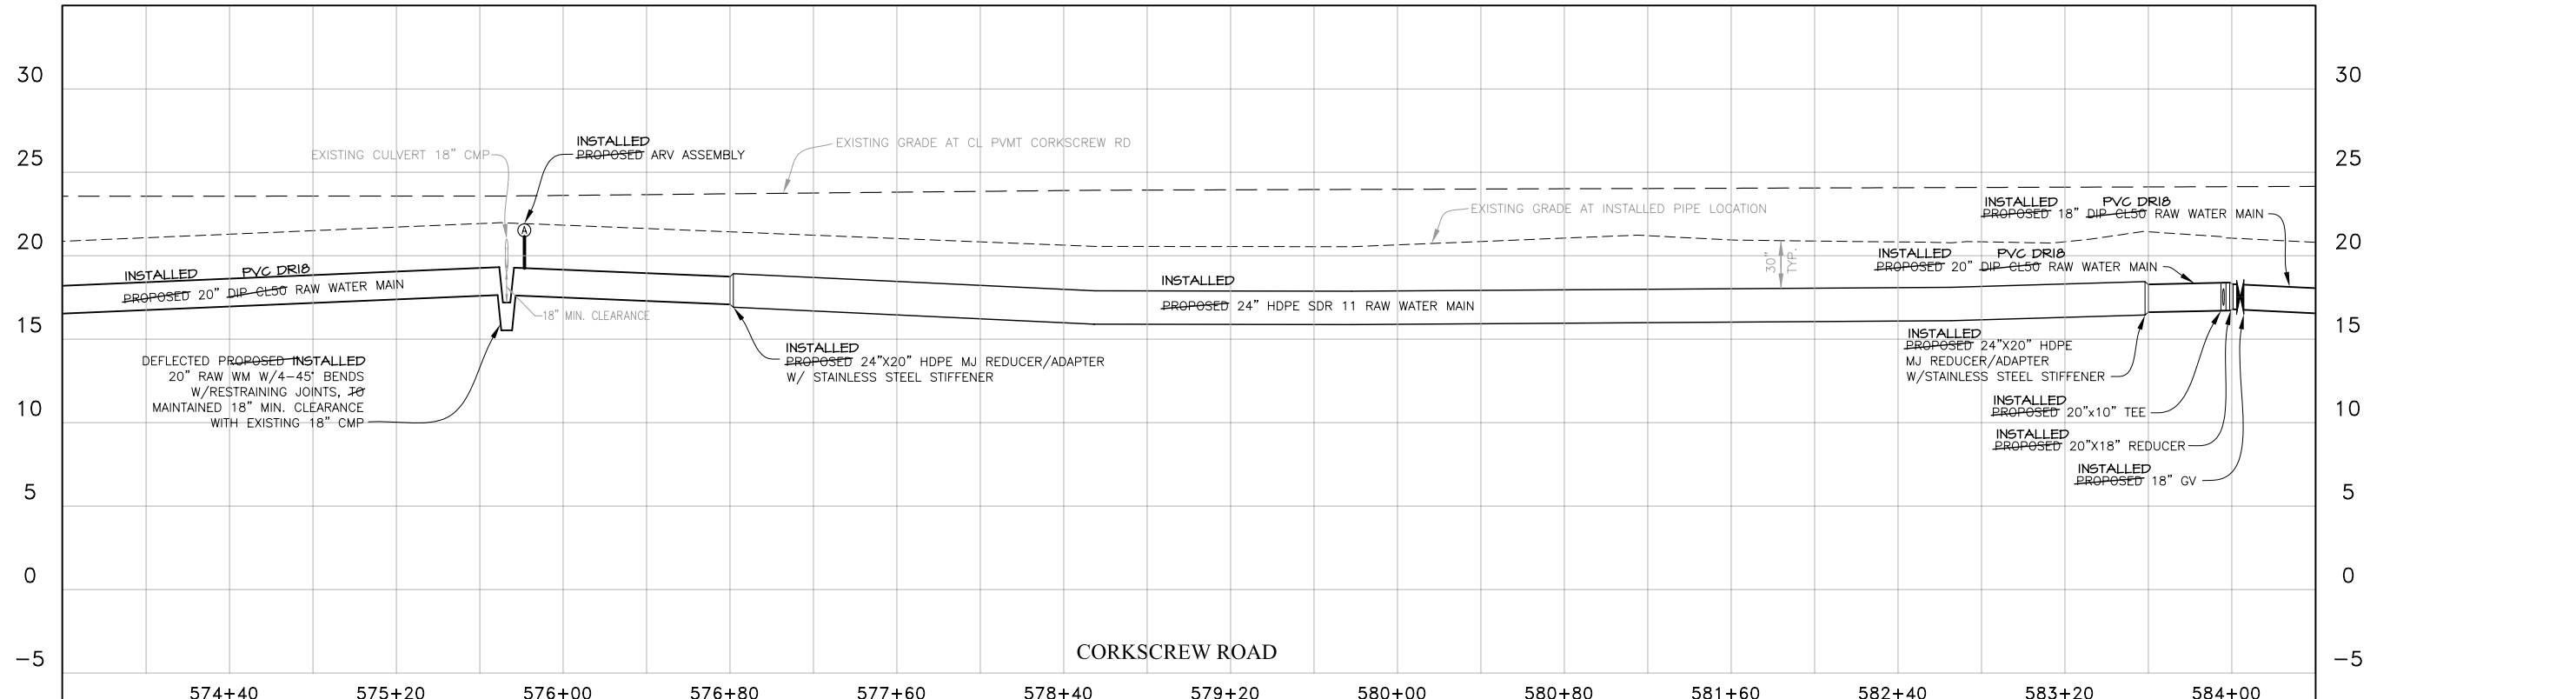


SEE SHEET PP 16  
MATCHLINE STA. 573+60

MATCHLINE STA. 584+40  
SEE SHEET PP 18

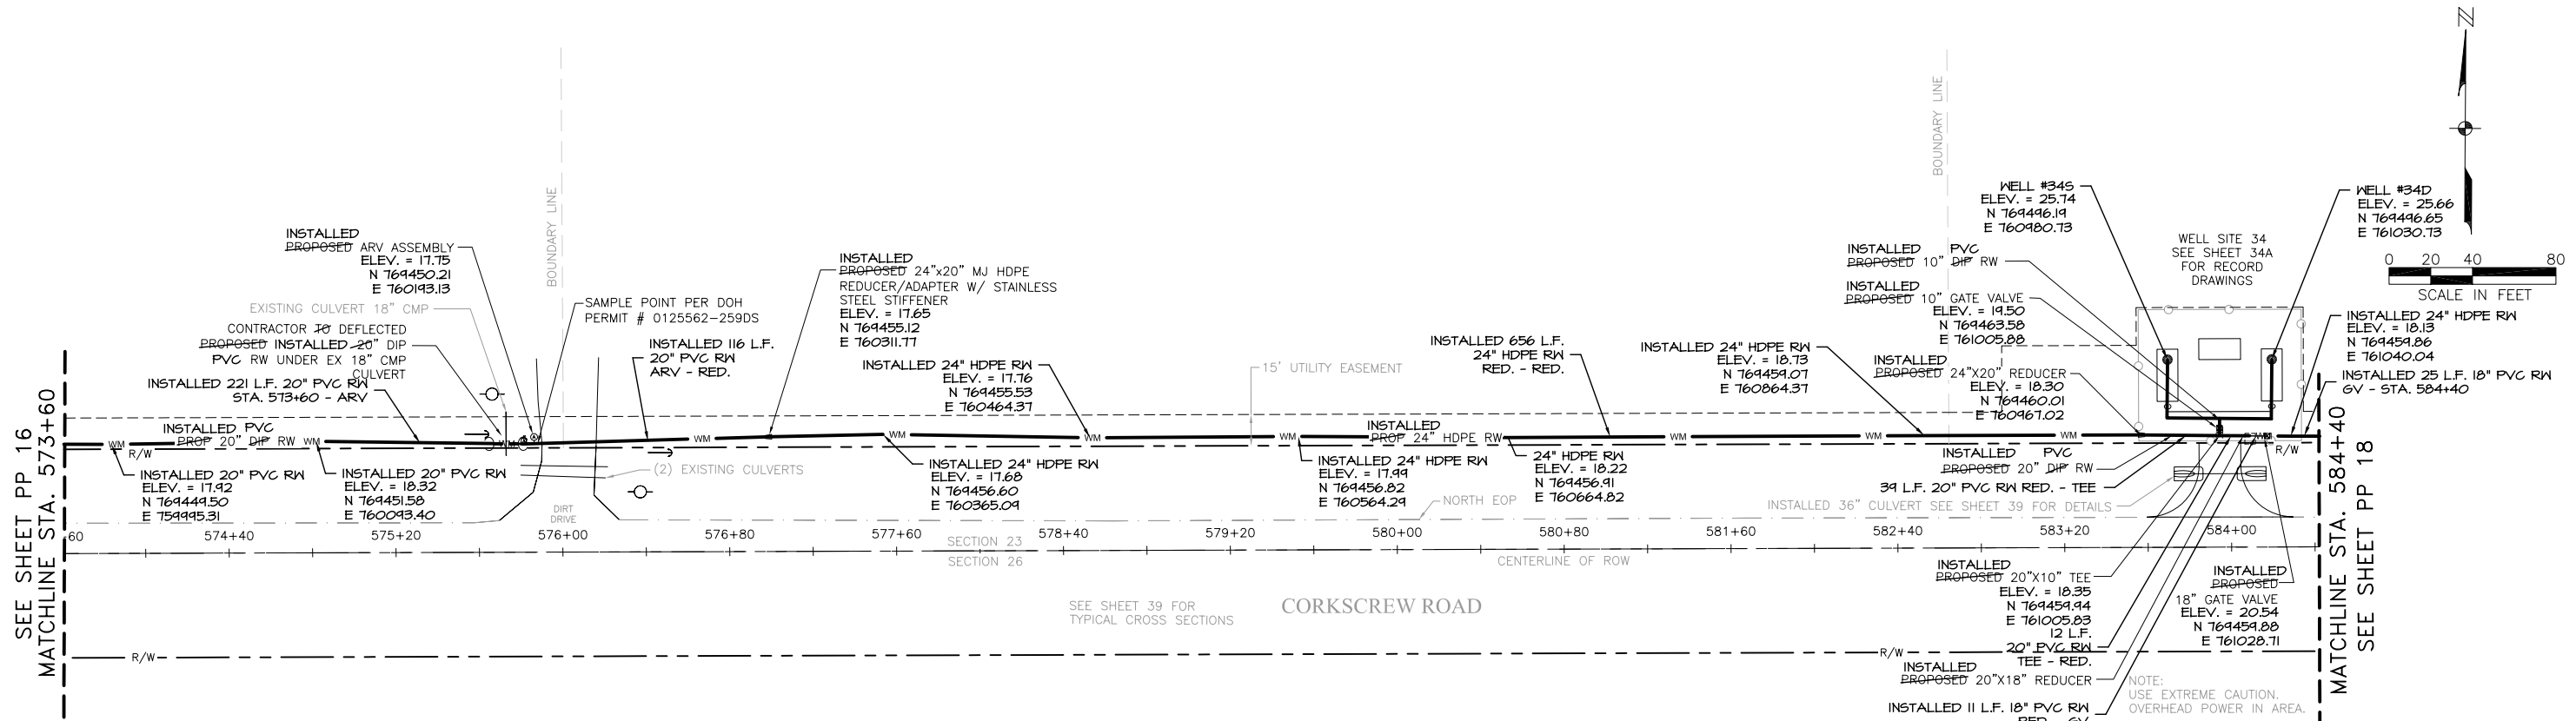

SCALE 1" = 40' HOR  
1" = 5' VER


**RECORD DRAWING**

N:\20033735\WaterMgmt\RECORD DRAWINGS\PP-WTP-to CorkscrewE2.dwg (PP 17) jwm Oct 06, 2009 - 8:05am

NO.	DATE	DESCRIPTION



Corkscrew 5 MGD  
Wellfield Expansion

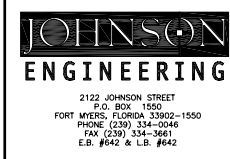

ERIK LEE HOWARD, PE  
FL License No. 66574

Plan and Profile - WTP to Corkscrew East  
Sta. 573+60 to Sta. 584+40

DATE	PROJECT NO.	FILE NO.	SCALE	SHEET
MARCH, 2006	20033735	16-46-26	As Shown	PP 17