
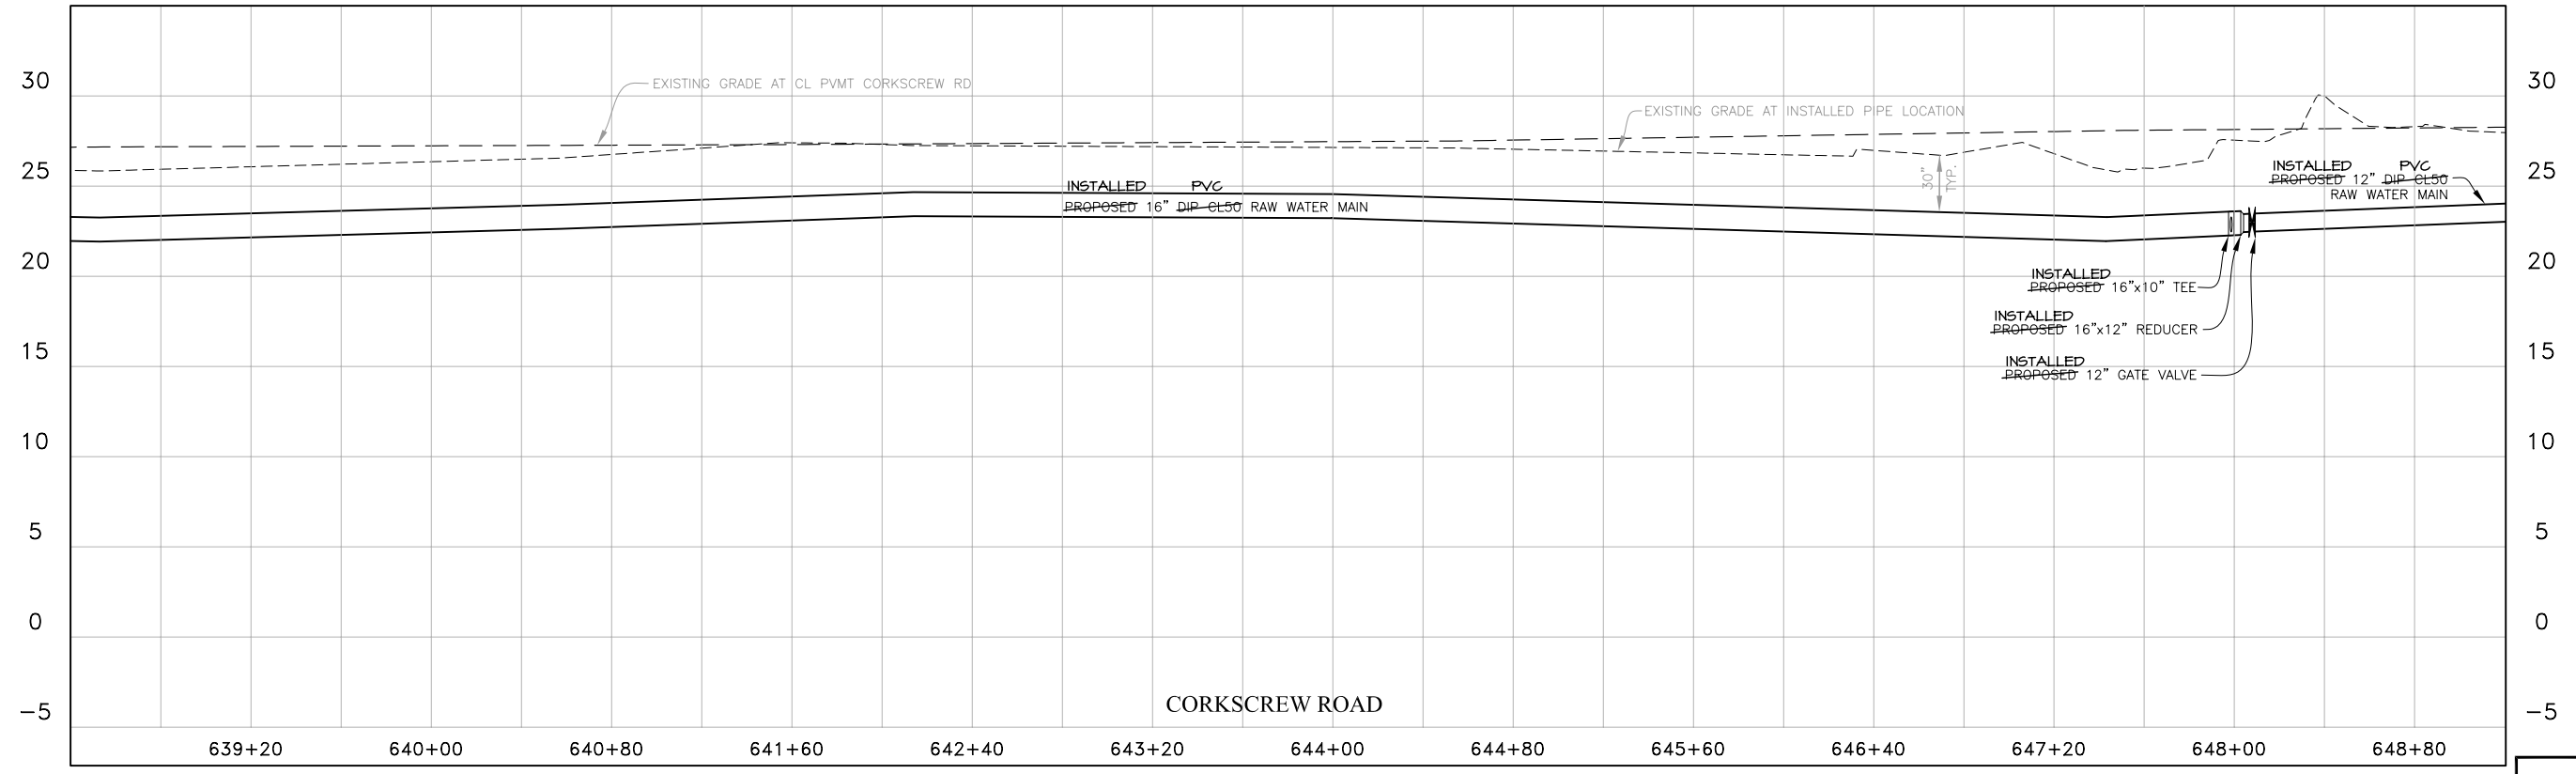
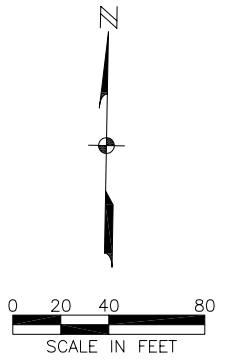


SEE SHEET PP 22
MATCHLINE STA. 638+40

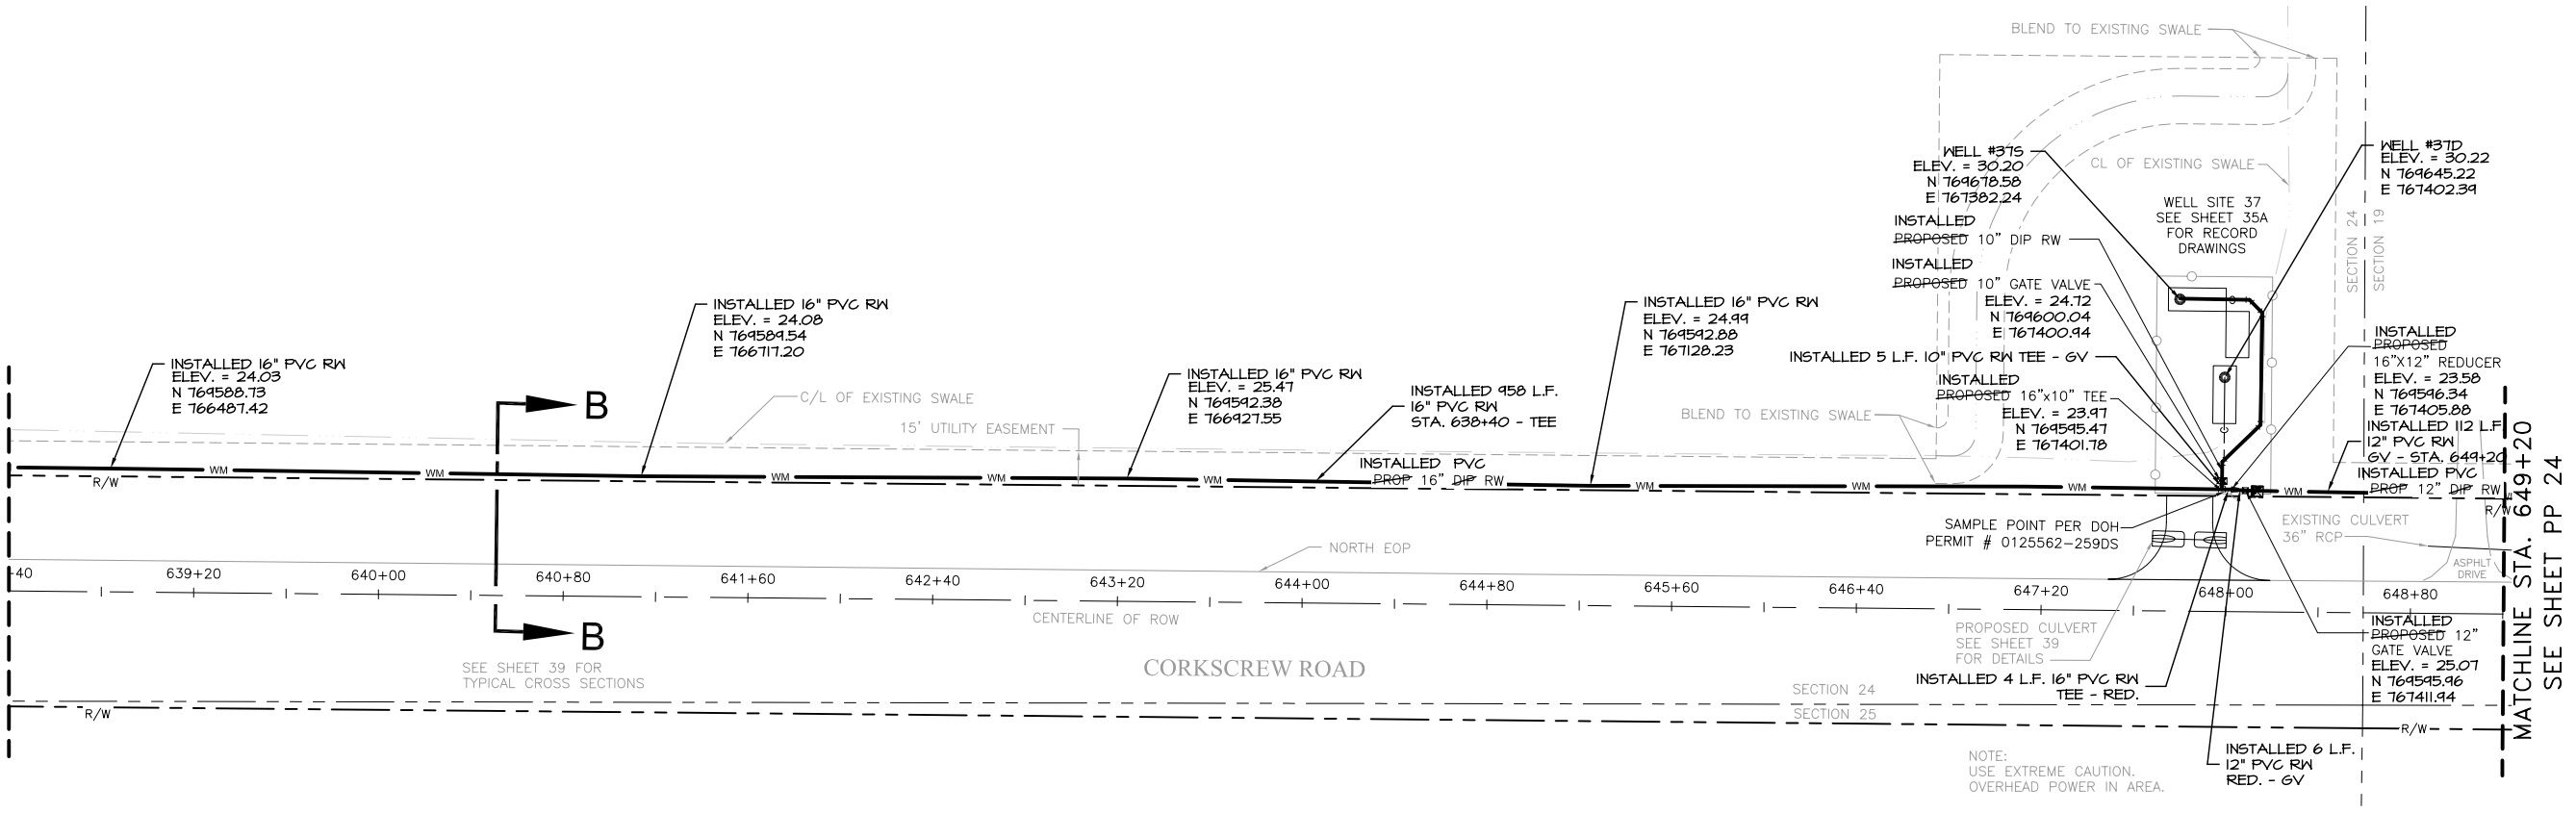

SCALE 1" = 40' HOR
1" = 5' VER


RECORD DRAWING

\\ftms01\proj-jel\20033735\WaterMgmt\RECORD DRAWINGS\PP-WTP_to CorkscrewE3.dwg (PP 23) jwm Oct 06, 2009 - 8:20am

REVISIONS	



Corkscrew 5 MGD
Wellfield Expansion

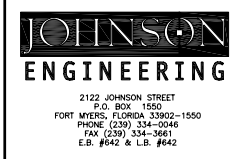

ERIK LEE HOWARD, PE
FL License No. 66574

Plan and Profile - WTP to Corkscrew East
Sta. 638+40 to Sta. 649+20

DATE	PROJECT NO.	FILE NO.	SCALE	SHEET
MARCH, 2006	20033735	16-46-26	As Shown	PP 23